


2 SEWER ISOMETRIC
NOT TO SCALE



1 SEWER PIPING PLAN
3/16" = 1'-0"

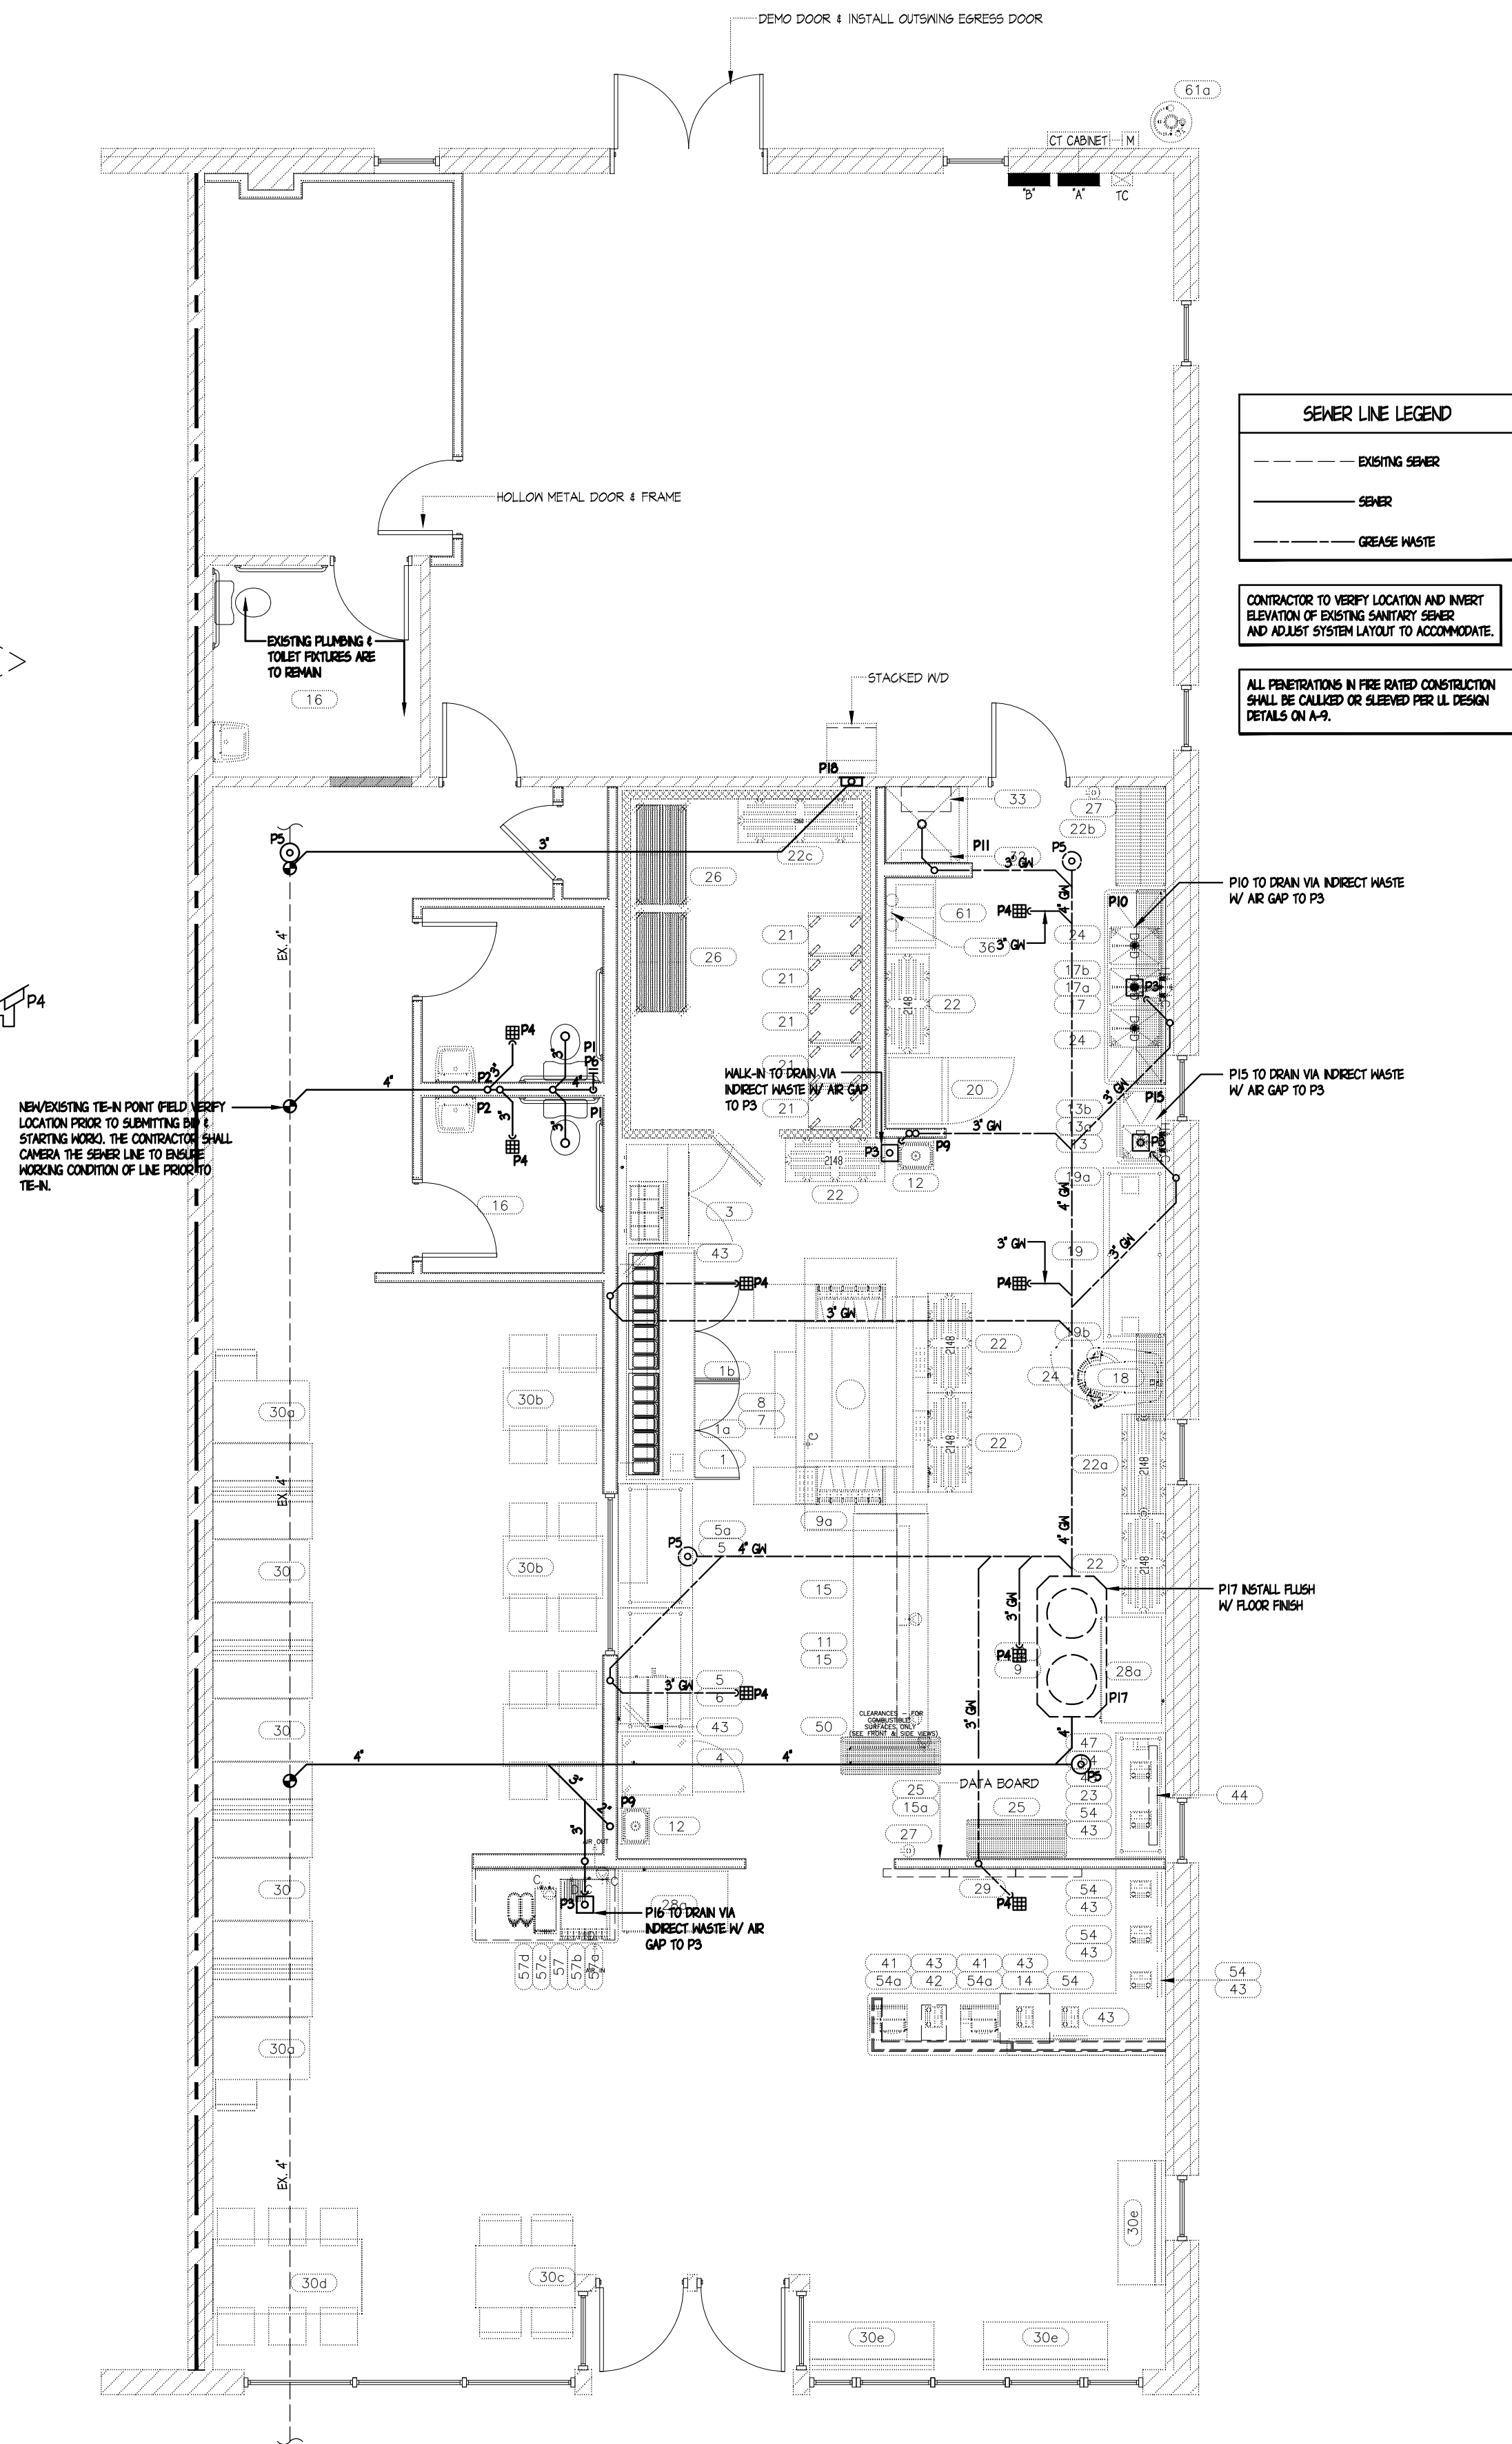

GERALD P. NOE
ARCHITECT

N.C. REGISTRATION NO. 6568

399 LUCERNE DRIVE
SPARTANBURG, SC 29302
P: 864.583.2215 F: 864.583.2265
mail@gpnarcht.com

CHECKED BY: DKH
DRAWN BY: LMP, DKH

THIS DRAWING IS AN INSTRUMENT OF
SERVICE AND SOLE PROPERTY OF THE
ARCHITECT, AND SHALL NOT BE USED
IN ANY WAY, WHATSOEVER, WITHOUT THE
WRITTEN PERMISSION OF THE ARCHITECT.
IT SHALL BE RETURNED TO THE ARCHITECT
UPON DEMAND.

COPYRIGHT 2017
ALL RIGHTS RESERVED

DATE: 08-03-2017

REVISIONS:

NO.	DATE	DESCRIPTION	BY
-----	------	-------------	----

CLIENT NAME:

MP MD, LLC.

RYAN SPRING
311 PALMER DRIVE
LEXINGTON, SOUTH CAROLINA 29072

PROJECT NAME:

marco's **PIZZA** **UP-FIT**
310 7th AVENUE EAST
HENDERSONVILLE, NORTH CAROLINA

SHEET TITLE:

SEWER PLAN

PROJECT NUMBER 17-A087

DATE 08-03-2017

SHEET NO.

AP-1

SHEET 1 OF 3